


RE: TO SHEETS A1.1 - A1.3 FOR ENLARGED PLANS

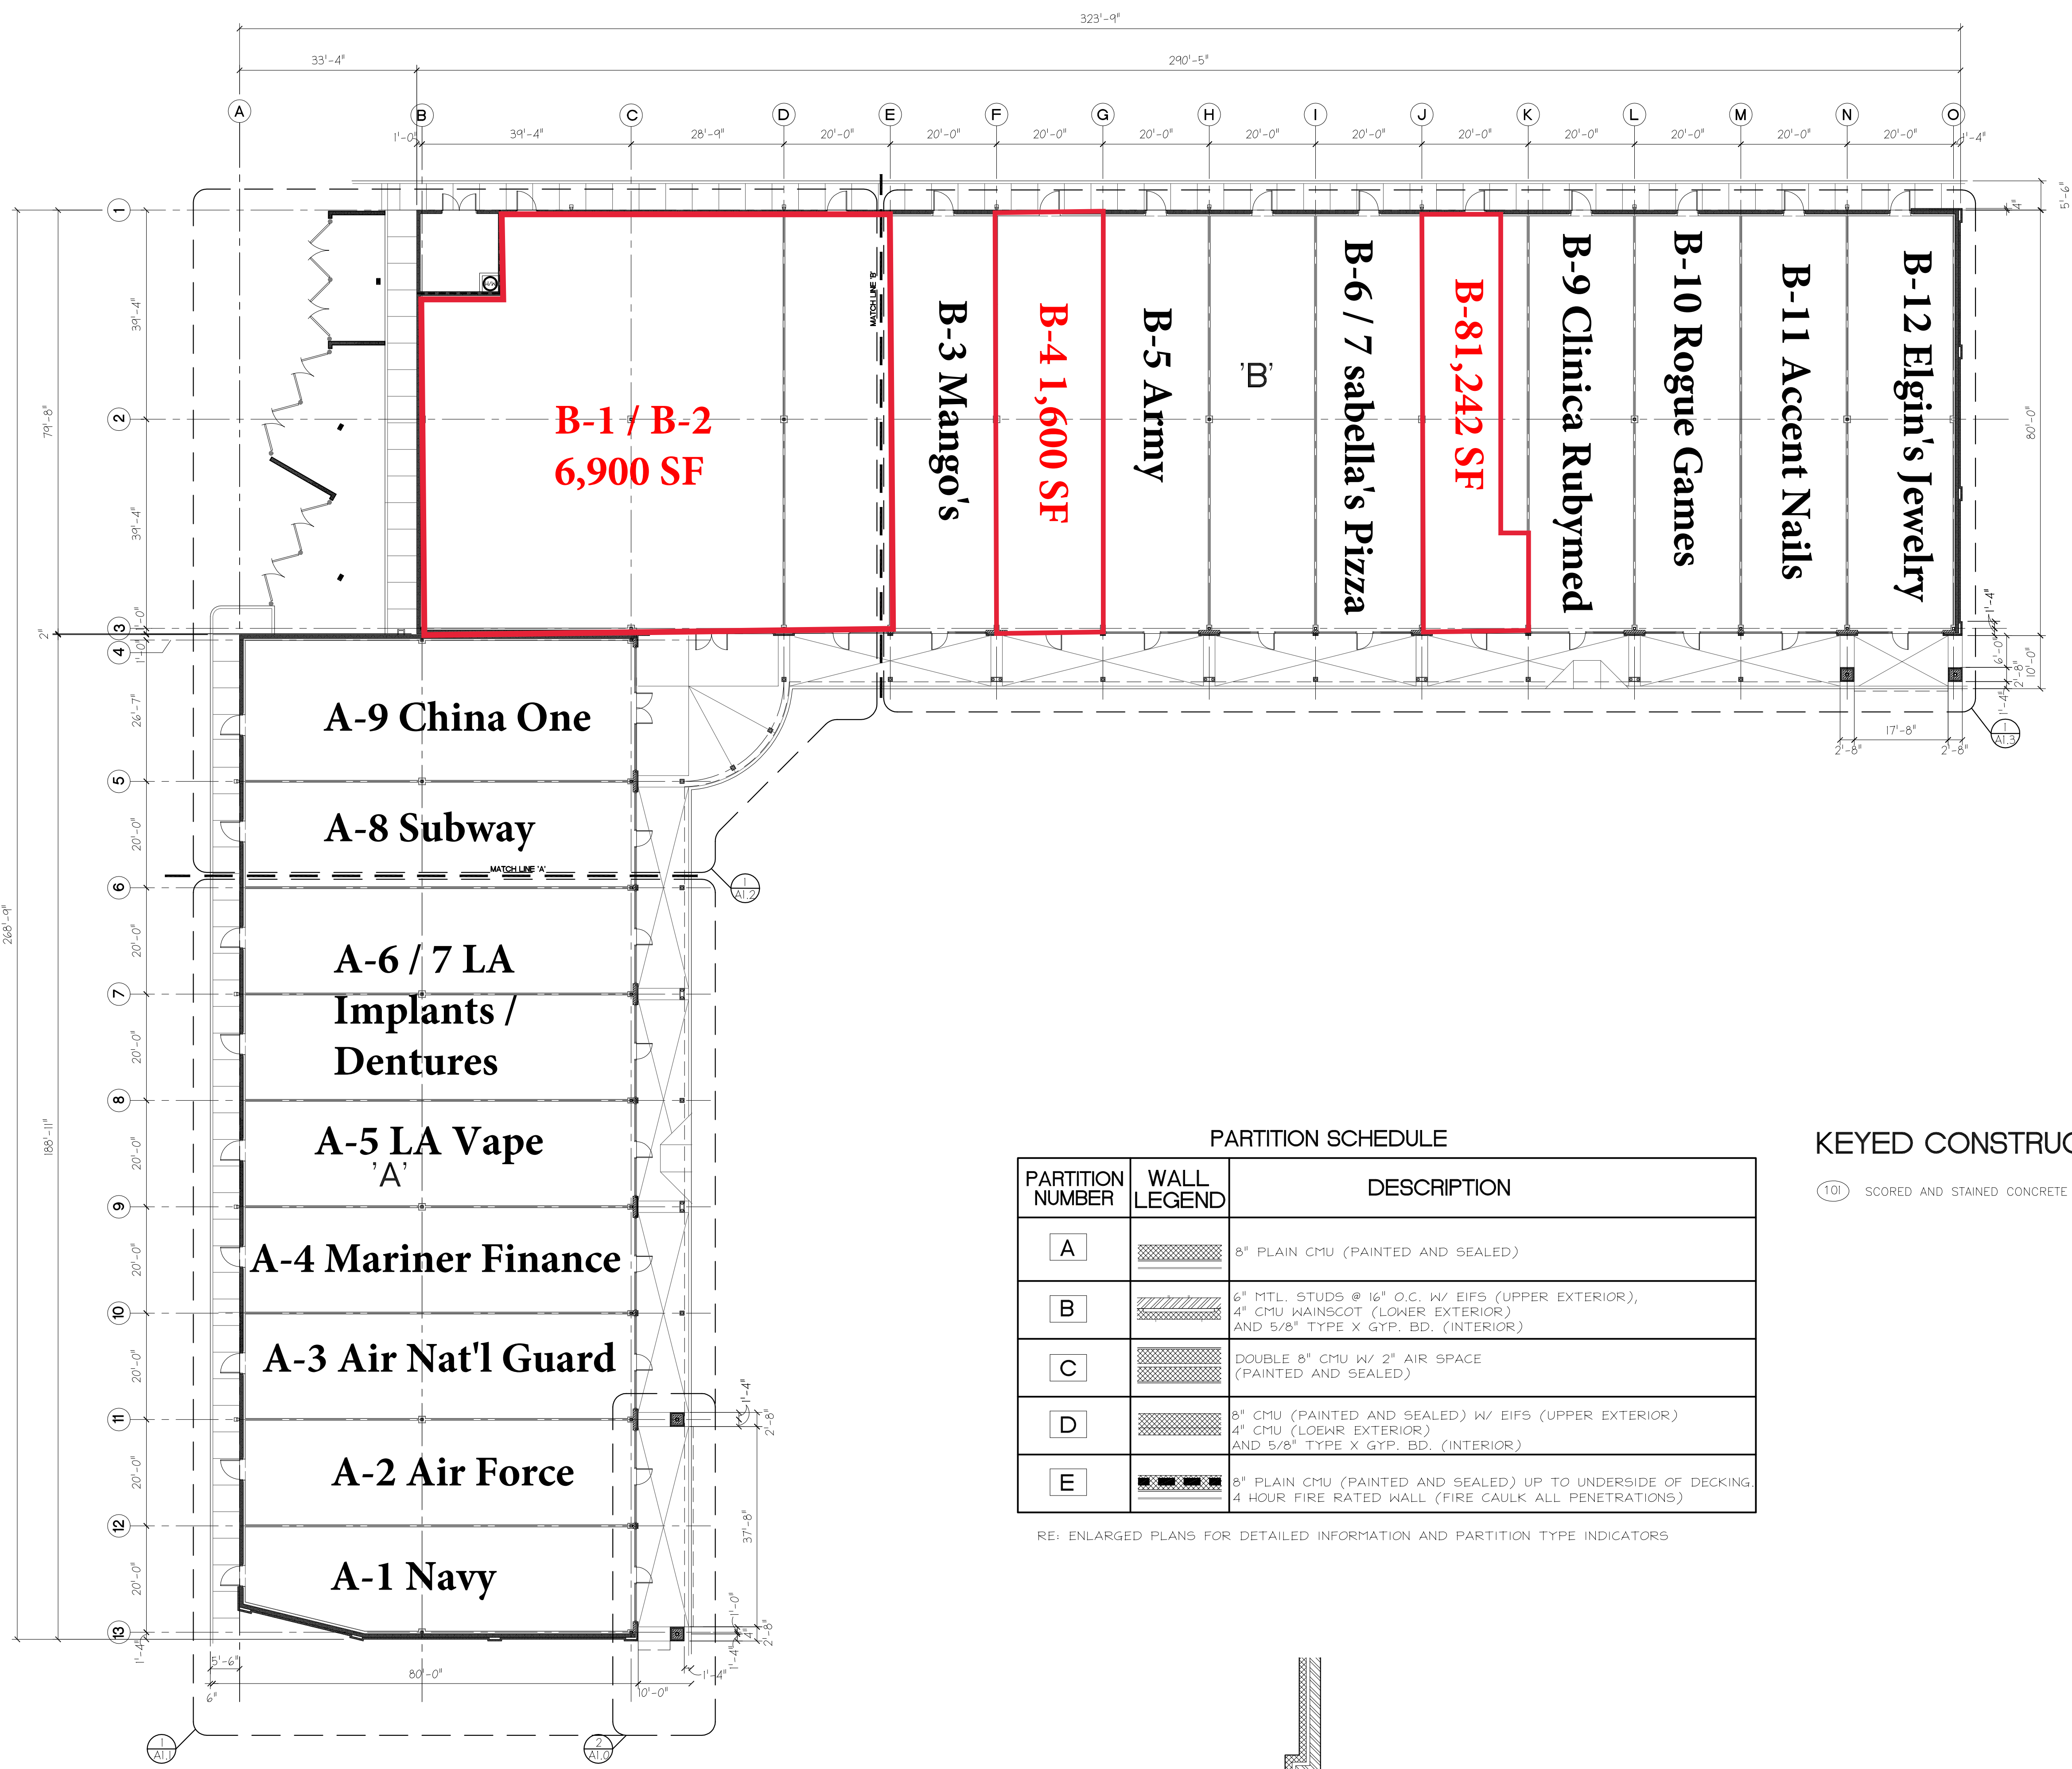

**B-1 / B-2  
6,900 SF**

**B-3  
Mango's**

**B-4  
1,600 SF**

**B-5  
Army**

**B-6 / 7  
Sabella's Pizza**

**B-8  
1,242 SF**

**B-9  
Clinica Rubymed**

**B-10  
Rogue Games**

**B-11  
Accent Nails**

**B-12  
Elgin's Jewelry**

**A-9  
China One**

**A-8  
Subway**

**A-6 / 7  
LA Implants /  
Dentures**

**A-5  
LA Vape  
'A'**

**A-4  
Mariner Finance**

**A-3  
Air Nat'l Guard**

**A-2  
Air Force**

**A-1  
Navy**

**PARTITION SCHEDULE**

PARTITION NUMBER	WALL LEGEND	DESCRIPTION
A	[Pattern]	8" PLAIN CMU (PAINTED AND SEALED)
B	[Pattern]	6" MTL. STUDS @ 16" O.C. W/ EIFS (UPPER EXTERIOR), 4" CMU WAINSCOT (LOWER EXTERIOR) AND 5/8" TYPE X GYP. BD. (INTERIOR)
C	[Pattern]	DOUBLE 8" CMU W/ 2" AIR SPACE (PAINTED AND SEALED)
D	[Pattern]	8" CMU (PAINTED AND SEALED) W/ EIFS (UPPER EXTERIOR) 4" CMU (LOEHR EXTERIOR) AND 5/8" TYPE X GYP. BD. (INTERIOR)
E	[Pattern]	8" PLAIN CMU (PAINTED AND SEALED) UP TO UNDERSIDE OF DECKING 4 HOUR FIRE RATED WALL (FIRE CAULK ALL PENETRATIONS)

RE: ENLARGED PLANS FOR DETAILED INFORMATION AND PARTITION TYPE INDICATORS


**KEYED CONSTRUCTION NOTES**

(10) SCORED AND STAINED CONCRETE SIDEWALK. SEE FINISH SPECS (SHT. A7.0).

**STAINED CONCRETE INSTRUCTIONS & SPECIFICATIONS:**

- CONCRETE TO BE STAINED SHALL BE MADE SLIP RESISTANT BY LIGHTLY SANDBLASTING OR ACID WASHING.
  - SCORE FLOOR IN PATTERN SHOWN WITH APPROPRIATE CUTTING TOOL APPROXIMATELY 1/8" WIDE X 1/8" DEEP.
  - STAIN FLOOR IN COLORS SHOWN ON PLAN (SEE SHEET A7.0 FOR COLOR DESIGNATIONS) AND SEAL WITH CLEAR SEALER. FLOOR SURFACE SHALL HAVE A SLIP RESISTANCE GREATER THAN OR EQUAL TO THAT REQUIRED BY A.D.A. SUPPLY GRIT FINISH AS NECESSARY IN ACCORDANCE W/ MFR. RECOMMENDED APPLICATION.
- ALL CONCRETE SURFACES DESIGNATED IN THE PLANS AND SPECIFICATIONS AS BEING CHEMICALLY STAINED SHALL RECEIVE TWO APPLICATIONS OF LITHOCHROME CHEMSTAIN IN COLORS DESIGNATED ON THE PLANS AFTER THE CONCRETE HAS CURED A MINIMUM OF 14 DAYS. THE SURFACE SHALL BE PREPARED AND LITHOCHROME CHEMSTAIN SHALL BE APPLIED IN ACCORDANCE WITH THE SCOFIELD TECH-DATA BULLETIN A-414 USING THE RECOMMENDED MINIMUM COVERAGE RATE. ALL CHEMICALLY STAINED SURFACES SHALL BE SEALED WITH TWO COATS OF CEMENTONE CLEAR SEALER IN ACCORDANCE WITH THE SCOFIELD TECH-DATA BULLETIN A-764. CEMENTONE CLEAR SEALER SHALL BE APPLIED FULL STRENGTH. SEALER SHALL HAVE HIGH GLOSS FINISH.
- ALL PRODUCTS SHALL BE MANUFACTURED BY L.M. SCOFIELD COMPANY.

GENERAL DIMENSIONING NOTES:  
 -OVERALL EXTERIOR DIMENSIONS ARE TO OUTSIDE OF SHEATHING.  
 -DETAILED EXTERIOR DIMENSIONS ARE TO E.I.F.S. FEATURES.  
 -INTERIOR DIMENSIONS ARE TO FACE OF WALL UNLESS OTHERWISE NOTED.  
 -CONTRACTOR TO COORDINATE CRITICAL DIMENSIONS OF PLUMBING FIXTURES, MECHANICAL EQUIPMENT, ELEVATOR AND ANY OTHER APPLICABLE EQUIPMENT THAT REQUIRES EXACT CLEARANCES.

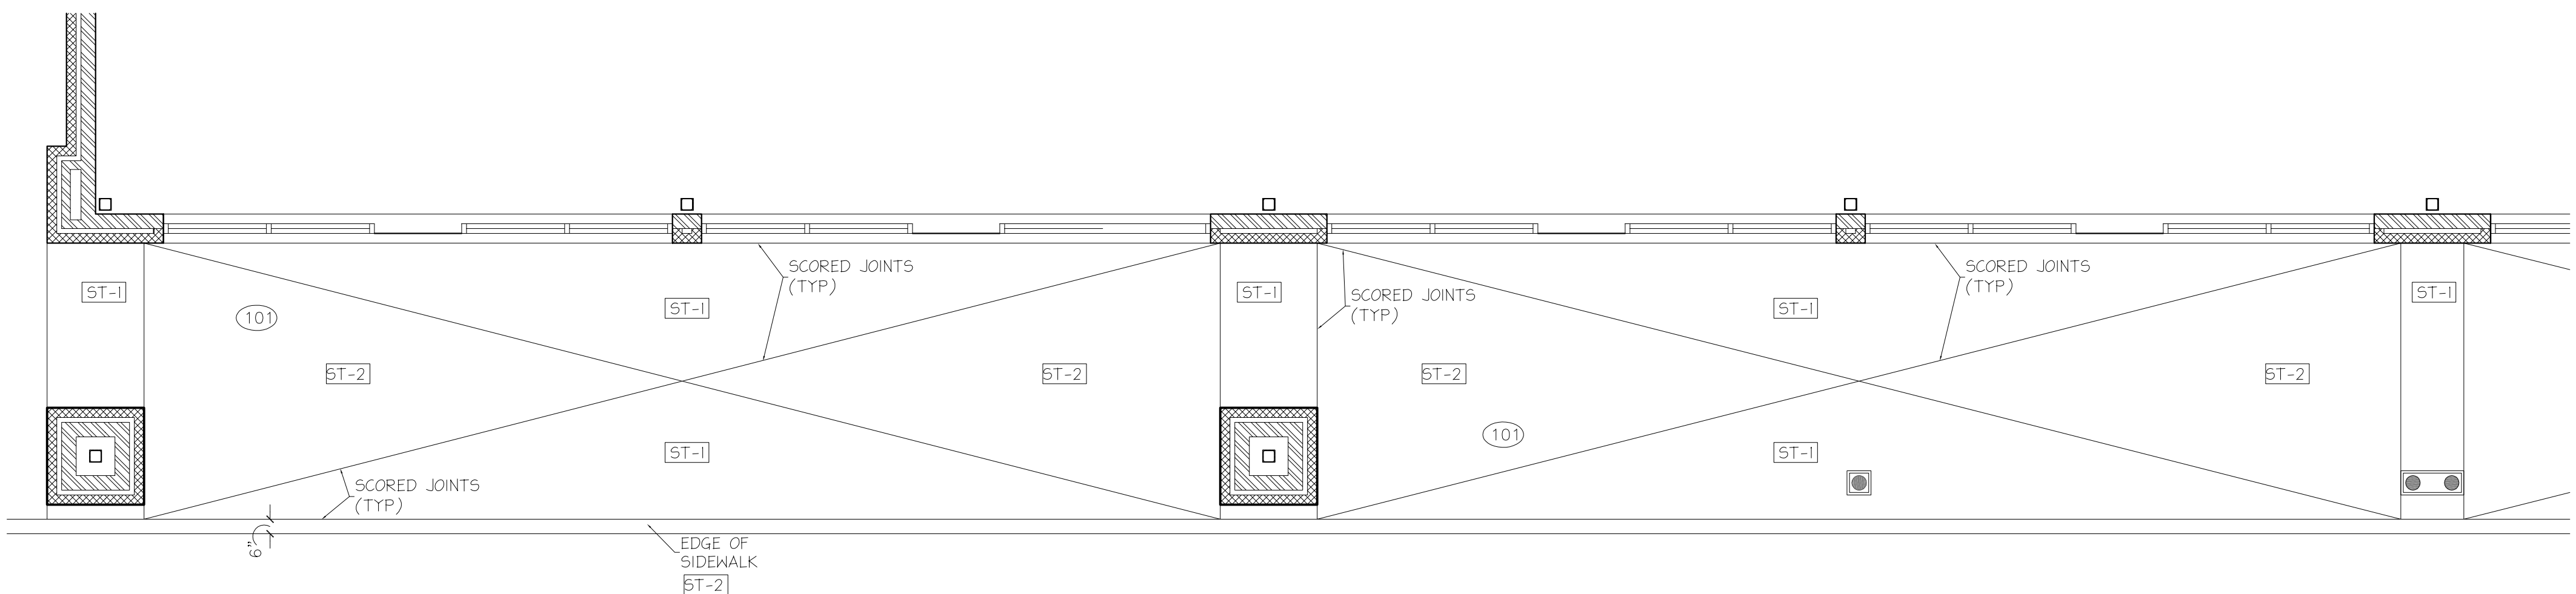

**1 DIMENSIONED FLOOR PLAN**  
 SCALE: 1/16" = 1'-0"

**2 TYPICAL SIDEWALK PLAN**  
 SCALE: 1/4" = 1'-0"

Design and specifications on instruments of service are and shall remain the property of the architect unless the project is not used for the project or reference in this project except by agreement in writing and with appropriate compensation to the architect.



**BLUEBONNET SQUARE**  
 AT BLUEBONNET BLVD + AIRLINE HWY.  
 BATON ROUGE, LA

03/06/08  
 DATE PROJECT NO. 07-758  
**A1.0**

REVISIONS